
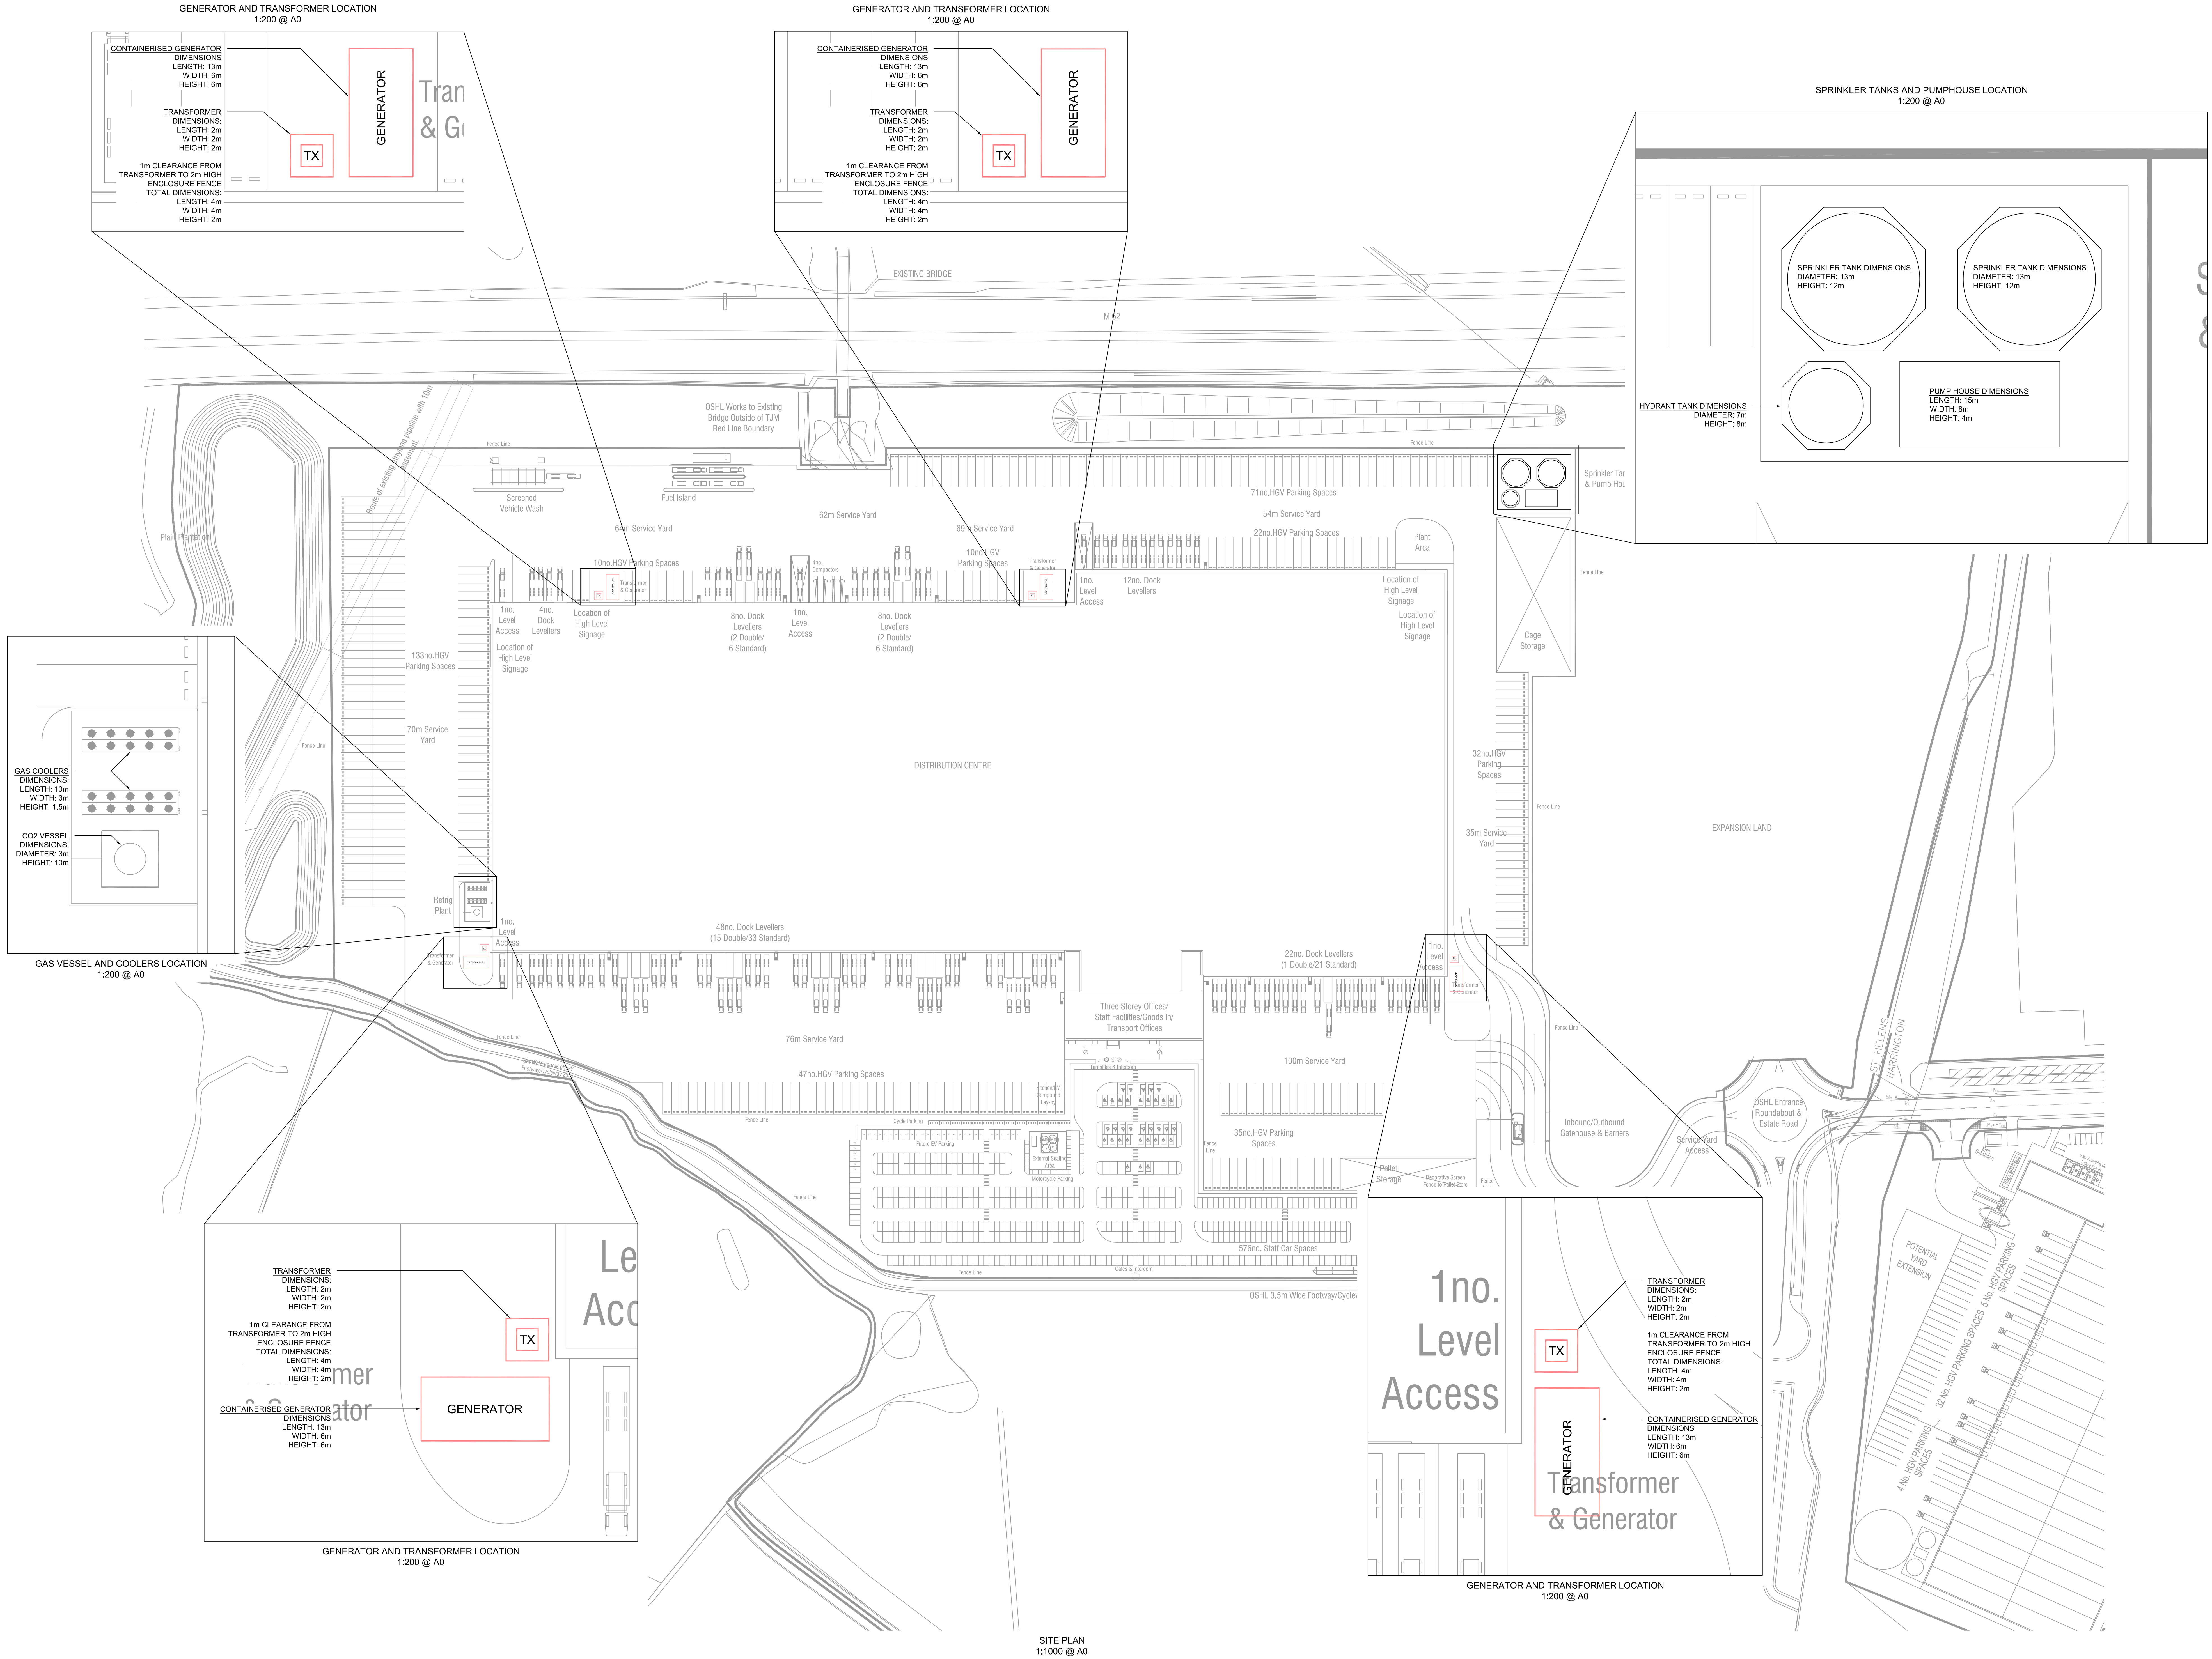


NOTES:

1. THIS DRAWING SHALL BE READ IN CONJUNCTION WITH THE RELEVANT MECHANICAL/ELECTRICAL SPECIFICATION AND ALL RELATED ARCHITECTS AND STRUCTURAL ENGINEERS DRAWINGS.

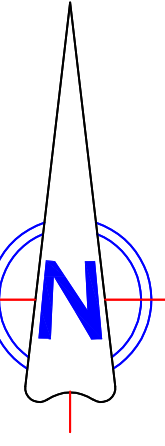

THIS DRAWING IS AN INDICATIVE LAYOUT ONLY, DEMONSTRATING THE CONCEPTUAL REQUIREMENTS CORRELATING WITH THE AGREED SCHEMATIC SOLUTIONS. THE PURPOSE OF THIS DRAWING IS TO DEMONSTRATE DESIGN INTENT, FOR FURTHER DEVELOPMENT BY THE RELEVANT SERVICES DESIGNER ONLY.

P4	07/05/20	FINAL COMMENTS ADDED.	UN	PMc
P3	07/05/20	GAS VESSEL AND COOLERS ADDED.	UN	PMc
P2	04/05/20	SPECIFIC MECH/PLANT DIMENSIONS.	UN	PMc
P1	04/11/19	POD INFORMATION.	GH	PMc
REV	DATE	DESCRIPTION	BY	VE

couchperrywilkes
engineering change

Birmingham | +44(0) 121 709 6600
Birmingham | +44(0) 115 924 3348
Birmingham | +44(0) 185 265 7488
Leeds | +44(0) 113 247 0759
Bristol | +44(0) 117 265 8281
Leicester | +44(0) 116 265 7397
London | +44(0) 202 572 4700
Manchester | +44(0) 161 976 7248

STATUS: FOR INFORMATION

CLIENT:

PROJECT: PROJECT HARVARD

DRAWING TITLE: MECHANICAL & ELECTRICAL PLANT LOCATIONS SKETCH UNIT 1 DWG.28

AS DETAILED NOV'19 GH PMc

CPW-190081-ME-SK-03 P4